
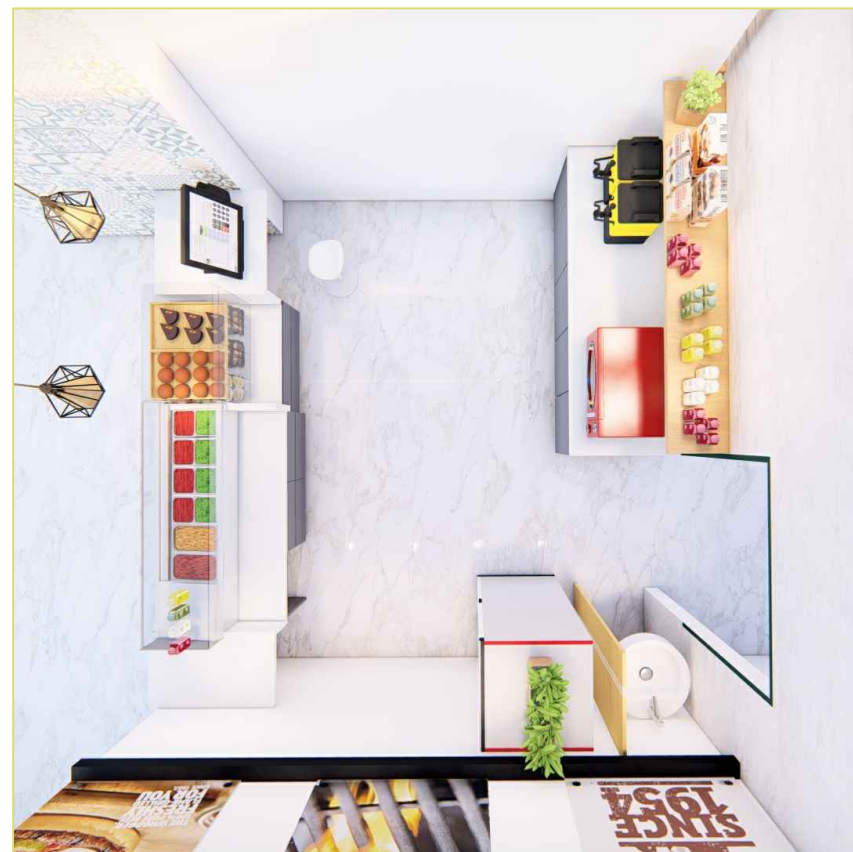


FRONT TOP PLAN

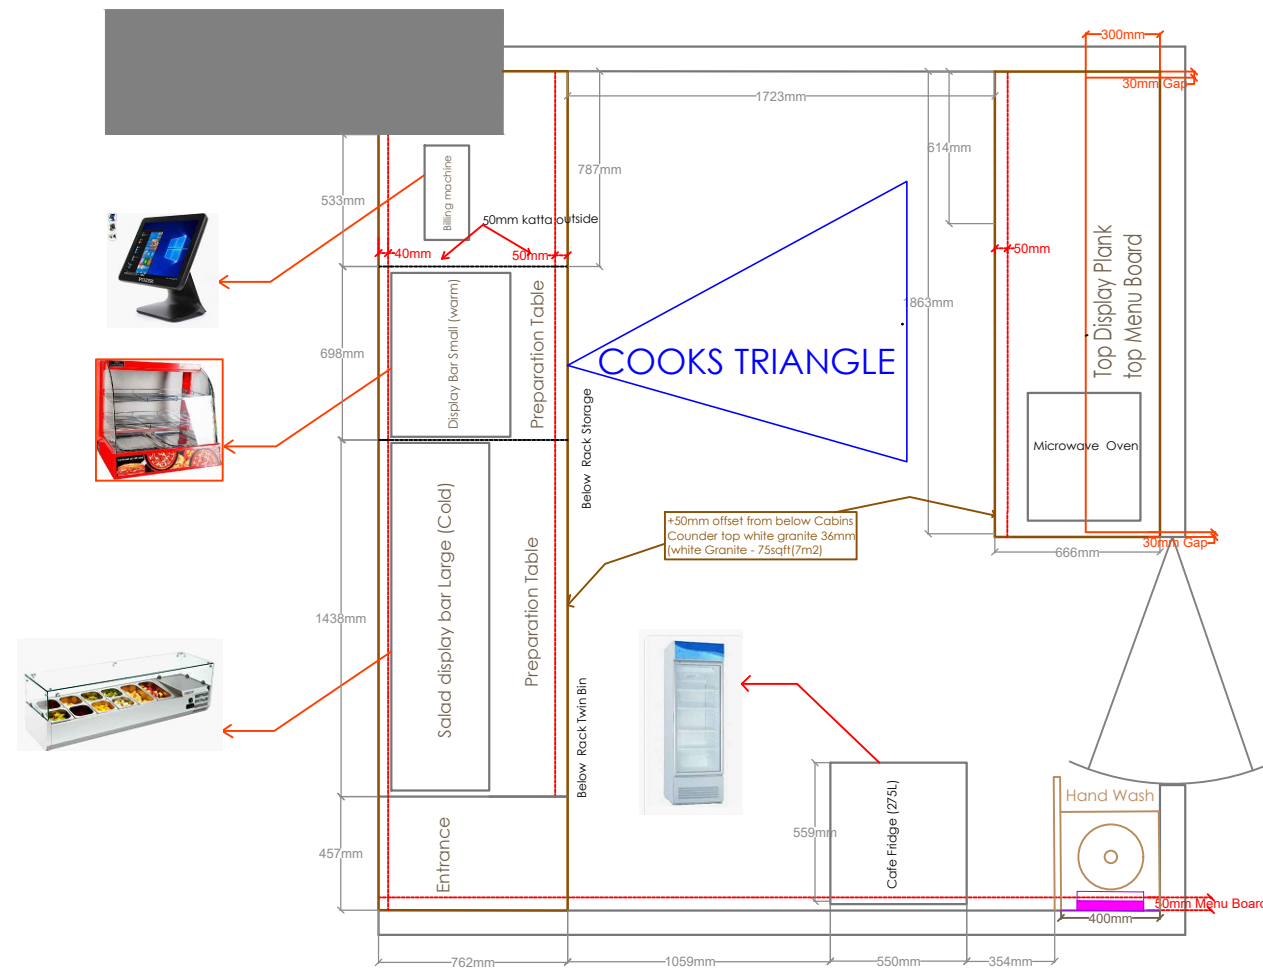

© THIS DRAWING IS THE PROPERTY OF ZA Construction (SHOP INTERIOR DESIGN) & NOT TO BE COPIED OR USED WITHOUT THEIR PERMISSION.

ALL DIMENSIONS SHALL BE CHECKED AND CO-RELATED WITH THE STRUCTURAL/WORKING DRG. AND ANY AMBIGUITY SHALL BE IMMEDIATELY BROUGHT TO THE NOTICE OF THE ARCHITECTS BEFORE IT'S EXECUTION. THIS DWG. SHOULD NOT BE SCALED AND ONLY WRITTEN DIMENSIONS TO BE FOLLOWED

REVISIONS	NO.	DATE
DISTRIBUTION OF PRINTS	NO.	DATE

PROJECT
**SustainAbite Cafe
at Dubai Production City**

OWNER'S NAME & SIGN.
Mr.Ammar


DRAWING TITLE
Front Top Plan

DWG. NO.	SCALE NTS	DATE
	DEALT BY ABDUSSAMI	

SHOP INTERIOR DESIGN.
Architecture | Interiors | Construction

Gandhi nagar, 1st main opp 4th cross,
Dharwad -580004.
cell: 9611993020.
zashopinteriordesign@gmail.com

Inner Front Wall Elevation

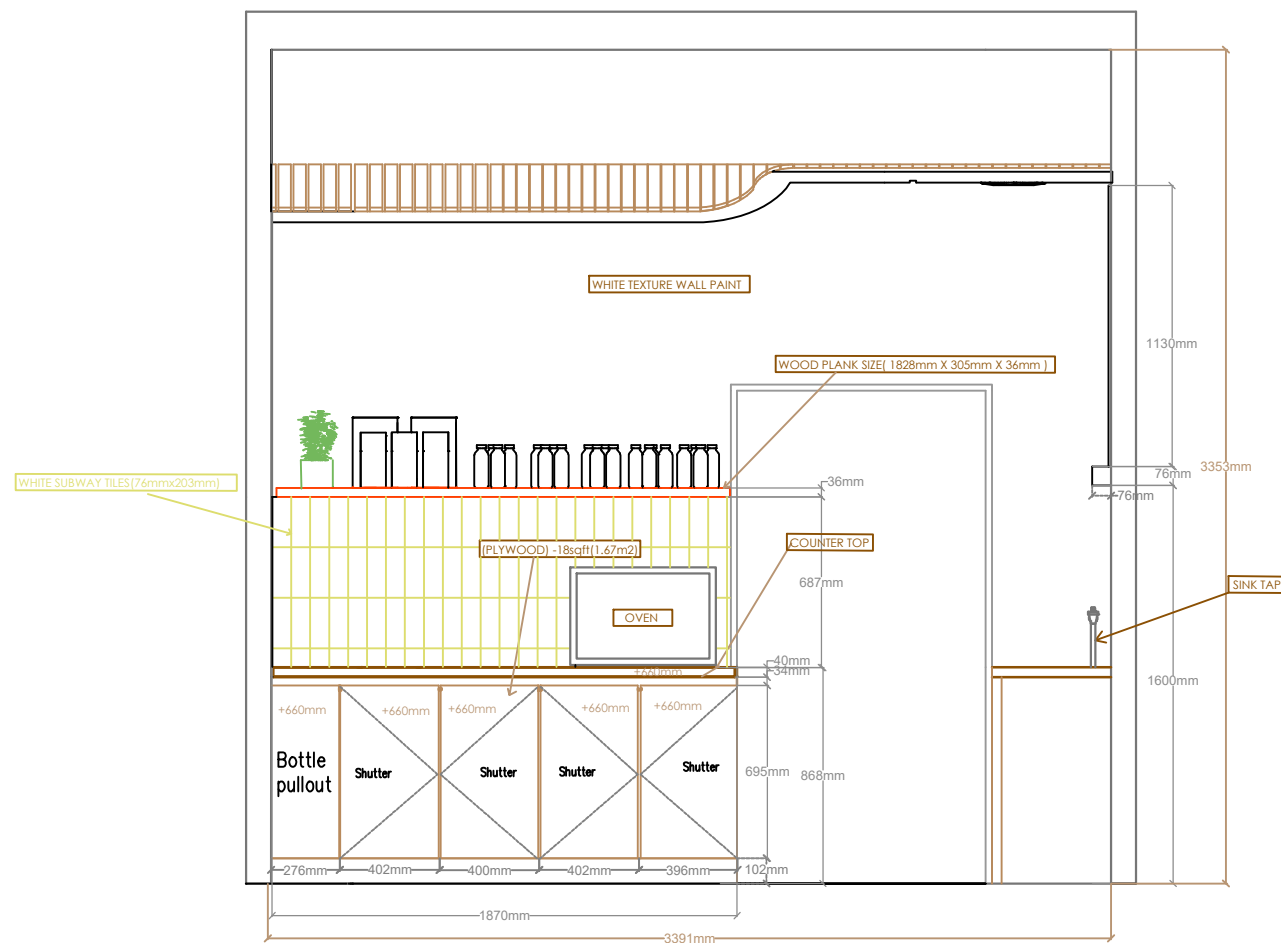

© THIS DRAWING IS THE PROPERTY OF ZA Construction (SHOP INTERIOR DESIGN) & NOT TO BE COPIED OR USED WITHOUT THEIR PERMISSION.

ALL DIMENSIONS SHALL BE CHECKED AND CO-RELATED WITH THE STRUCTURAL/WORKING DRG. AND ANY AMBIGUITY SHALL BE IMMEDIATELY BROUGHT TO THE NOTICE OF THE ARCHITECTS BEFORE IT'S EXECUTION. THIS DWG. SHOULD NOT BE SCALED AND ONLY WRITTEN DIMENSIONS TO BE FOLLOWED

REVISIONS	NO.	DATE
DISTRIBUTION OF PRINTS	NO.	DATE

PROJECT
**SustainAbite Cafe
at Dubai Production City**

OWNER'S NAME & SIGN.
Mr.Ammar

DRAWING TITLE
Inner Front Wall Elevation


DWG. NO.	SCALE NTS	DATE 03.04.2024
DEALT BY ABDUSSAMI	CHKD. BY SYB	

SHOP INTERIOR DESIGN.

Architecture | Interiors | Construction

Gandhi nagar, 1st main opp 4th cross,
Dharwad -580004.
cell: 9611993020.
zashopinteriordesign@gmail.com

Front Elevation

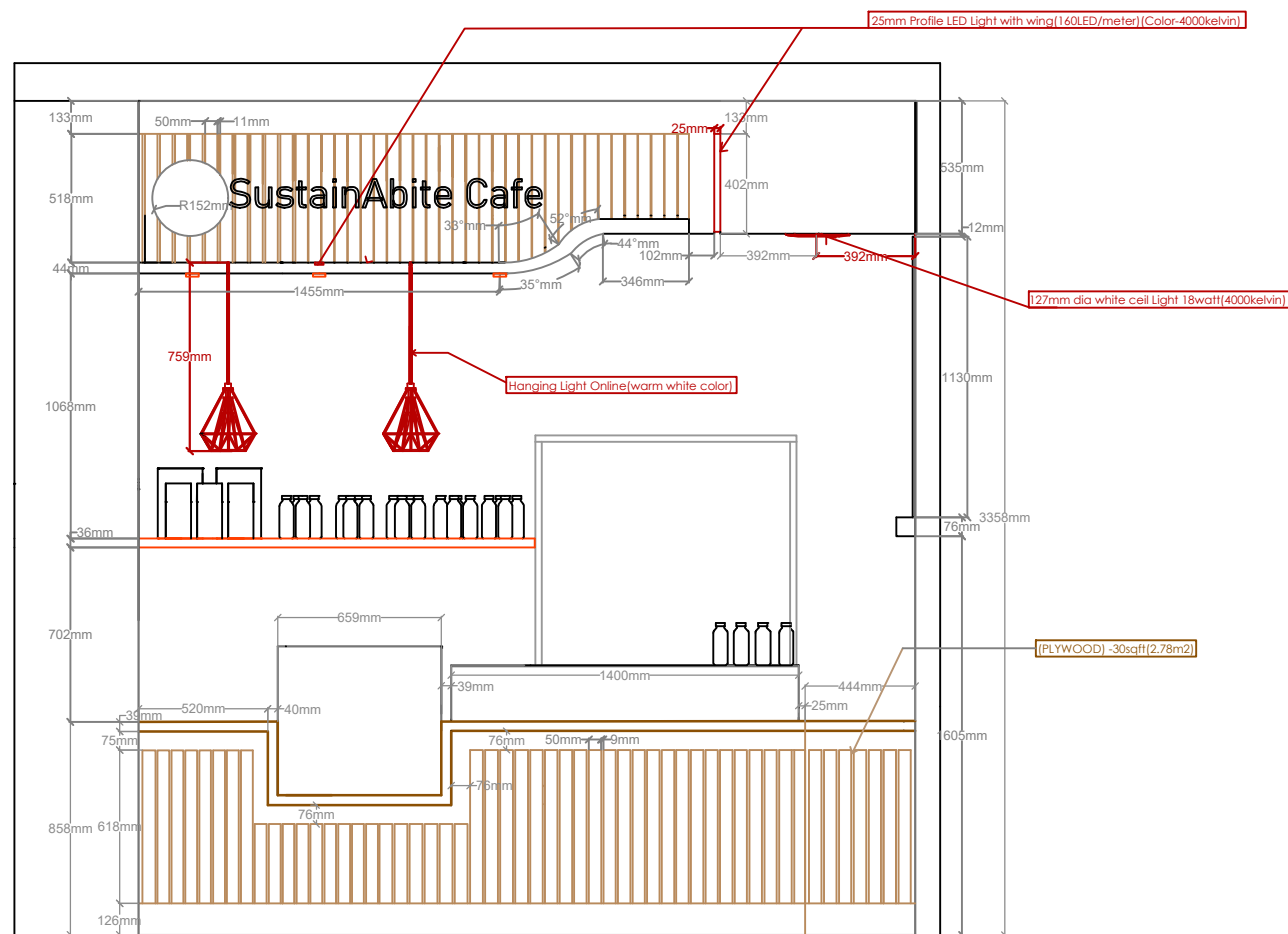

© THIS DRAWING IS THE PROPERTY OF ZA Construction (SHOP INTERIOR DESIGN) & NOT TO BE COPIED OR USED WITHOUT THEIR PERMISSION.

ALL DIMENSIONS SHALL BE CHECKED AND CO-RELATED WITH THE STRUCTURAL/WORKING DRG. AND ANY AMBIGUITY SHALL BE IMMEDIATELY BROUGHT TO THE NOTICE OF THE ARCHITECTS BEFORE IT'S EXECUTION. THIS DWG. SHOULD NOT BE SCALED AND ONLY WRITTEN DIMENSIONS TO BE FOLLOWED

REVISIONS	NO.	DATE
DISTRIBUTION OF PRINTS	NO.	DATE

PROJECT

**SustainAbite Cafe
at Dubai Production City**

OWNER'S NAME & SIGN.

Mr.Ammar



DRAWING TITLE
Front Elevation

DWG. NO.	SCALE NTS	DATE 03.04.2024
	DEALT BY ABDUSSAMI	CHKD. BY SYB

SHOP INTERIOR DESIGN.
Architecture | Interiors | Construction

Gandhi nagar, 1st main opp 4th cross,
Dharwad -580004.
cell: 9611993020.
zashopinteriordesign@gmail.com

Inner Counter Wall Elevation

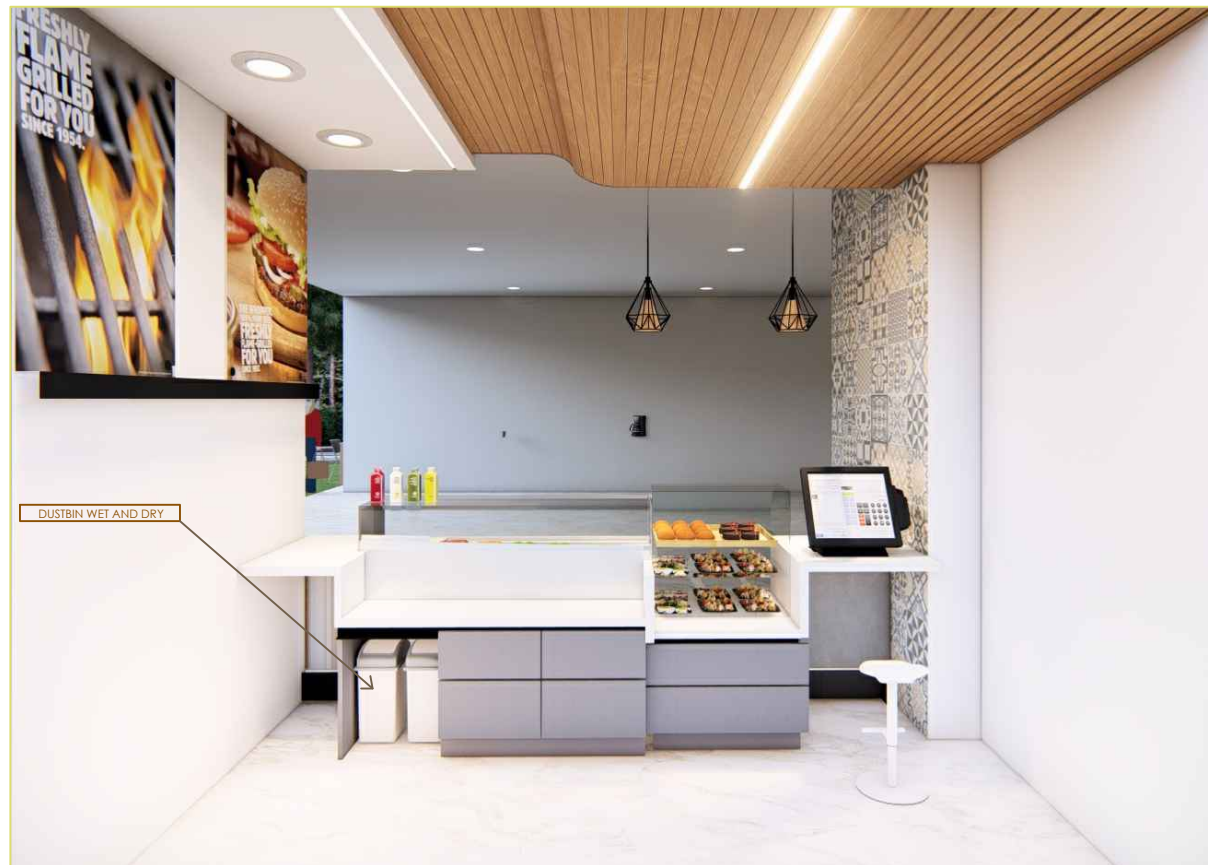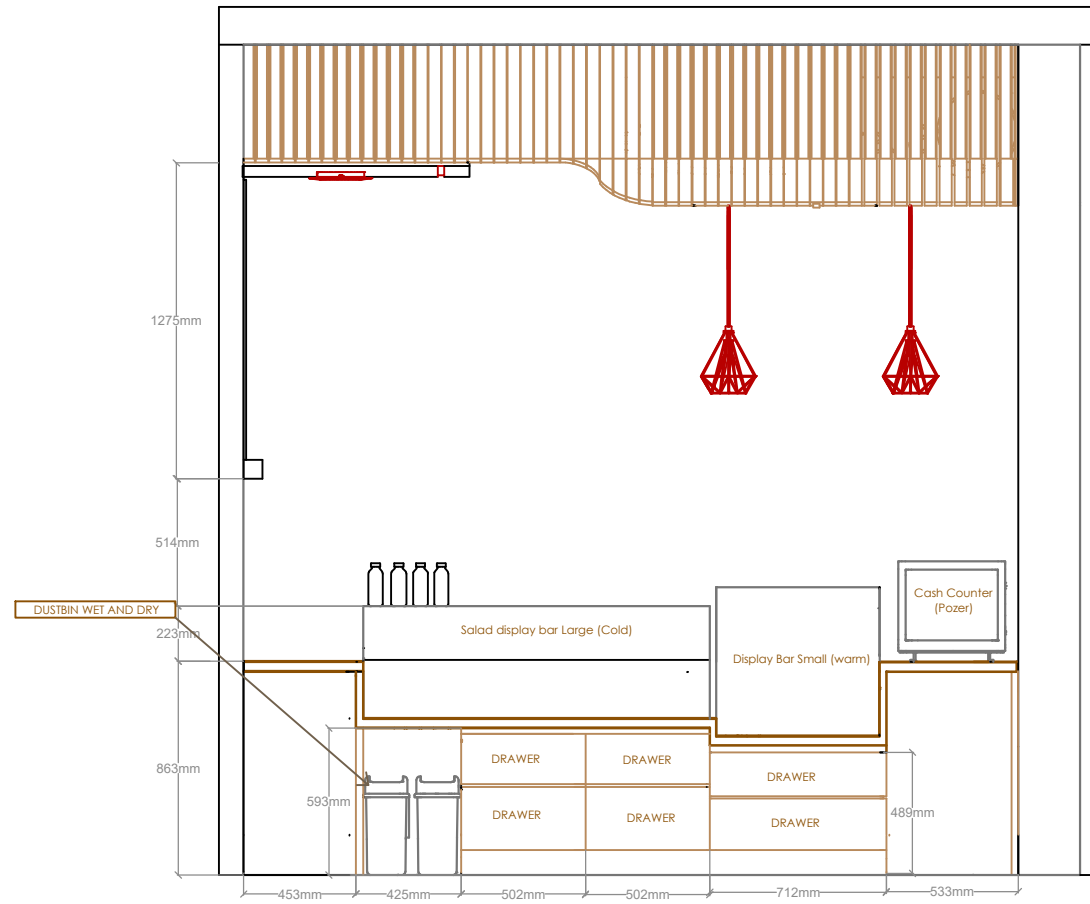

© THIS DRAWING IS THE PROPERTY OF ZA Construction (SHOP INTERIOR DESIGN) & NOT TO BE COPIED OR USED WITHOUT THEIR PERMISSION.

ALL DIMENSIONS SHALL BE CHECKED AND CO-RELATED WITH THE STRUCTURAL/WORKING DRG. AND ANY AMBIGUITY SHALL BE IMMEDIATELY BROUGHT TO THE NOTICE OF THE ARCHITECTS BEFORE IT'S EXECUTION. THIS DWG. SHOULD NOT BE SCALED AND ONLY WRITTEN DIMENSIONS TO BE FOLLOWED

REVISIONS	NO.	DATE
DISTRIBUTION OF PRINTS	NO.	DATE

PROJECT

SustainAbite Cafe
at Dubai Production City

OWNER'S NAME & SIGN.

Mr.Ammar


DRAWING TITLE
Front Elevation

DWG. NO.	SCALE	DATE
	NTS	
	DEALT BY	CHKD. BY
	ABDUSSAMI	SYB



Gandhi nagar, 1st main opp 4th cross,
Dharwad -580004.
cell: 9611993020.
zashopinteriordesign@gmail.com

Inner Poster Wall Elevation

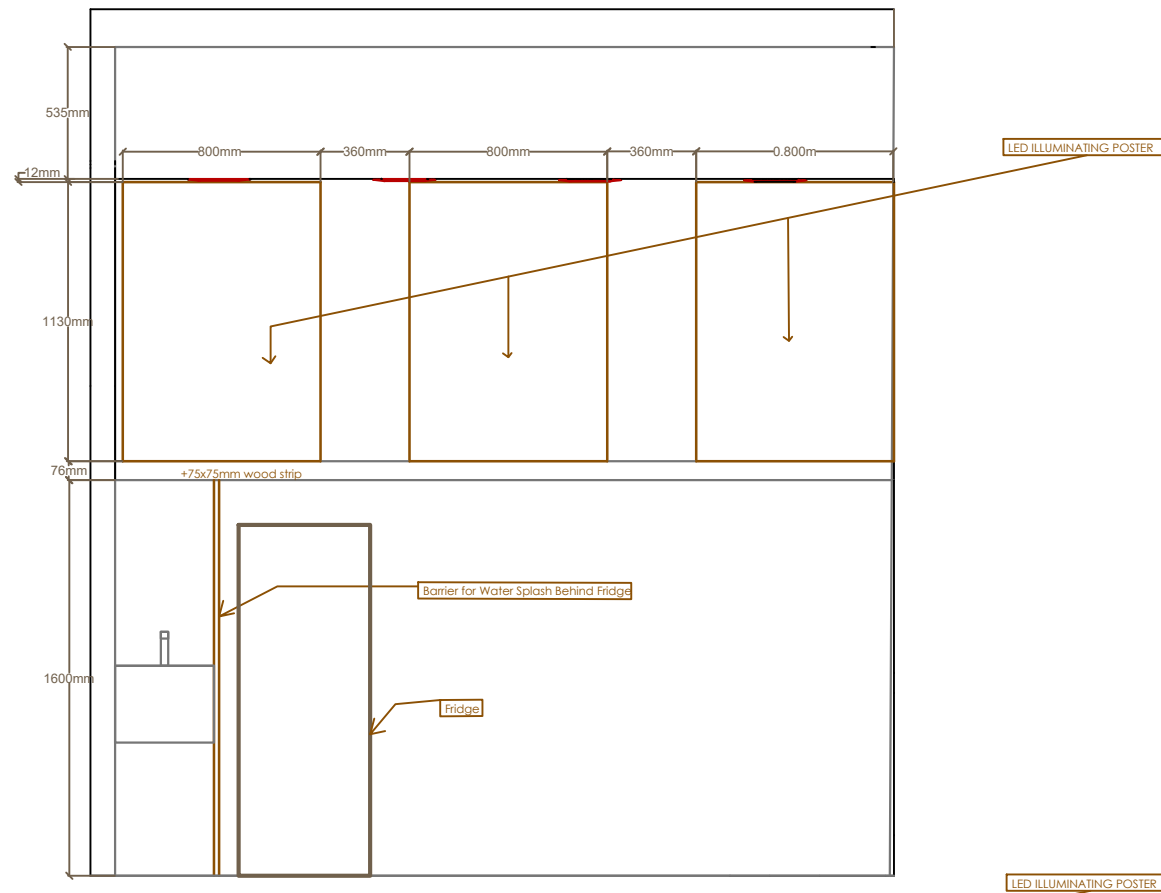

© THIS DRAWING IS THE PROPERTY OF ZA Construction (SHOP INTERIOR DESIGN) & NOT TO BE COPIED OR USED WITHOUT THEIR PERMISSION.

ALL DIMENSIONS SHALL BE CHECKED AND CO-RELATED WITH THE STRUCTURAL/WORKING DRG. AND ANY AMBIGUITY SHALL BE IMMEDIATELY BROUGHT TO THE NOTICE OF THE ARCHITECTS BEFORE IT'S EXECUTION. THIS DWG. SHOULD NOT BE SCALED AND ONLY WRITTEN DIMENSIONS TO BE FOLLOWED

REVISIONS	NO.	DATE
DISTRIBUTION OF PRINTS	NO.	DATE

PROJECT
**SustainAbite Cafe
at Dubai Production City**

OWNER'S NAME & SIGN.
Mr.Ammar

DRAWING TITLE
Front Elevation

DWG. NO.	SCALE	DATE
	NTS	03.04.2024
	DEALT BY ABDUSSAMI	CHKD. BY SYB



Gandhi nagar, 1st main opp 4th cross,
Dharwad -580004.
cell: 9611993020.
zashopinteriordesign@gmail.com

Front and Kitchen Plan



© THIS DRAWING IS THE PROPERTY OF ZA Construction (SHOP INTERIOR DESIGN) & NOT TO BE COPIED OR USED WITHOUT THEIR PERMISSION.

ALL DIMENSIONS SHALL BE CHECKED AND CO-RELATED WITH THE STRUCTURAL/WORKING DRG. AND ANY AMBIGUITY SHALL BE IMMEDIATELY BROUGHT TO THE NOTICE OF THE ARCHITECTS BEFORE IT'S EXECUTION. THIS DWG. SHOULD NOT BE SCALED AND ONLY WRITTEN DIMENSIONS TO BE FOLLOWED

REVISIONS	NO.	DATE
DISTRIBUTION OF PRINTS	NO.	DATE

PROJECT
SustainAbite Cafe
at Dubai Production City


OWNER'S NAME & SIGN.
Mr.Ammar

DRAWING TITLE
Front and Kitchen Plan


DWG. NO.	SCALE NTS	DATE 03.04.2024
	DEALT BY ABDUSSAMI	CHKD. BY SYB

SHOP INTERIOR DESIGN.
Architecture | Interiors | Construction

Gandhi nagar, 1st main opp 4th cross,
Dharwad -580004.
cell: 9611993020.
zashopinteriordesign@gmail.com

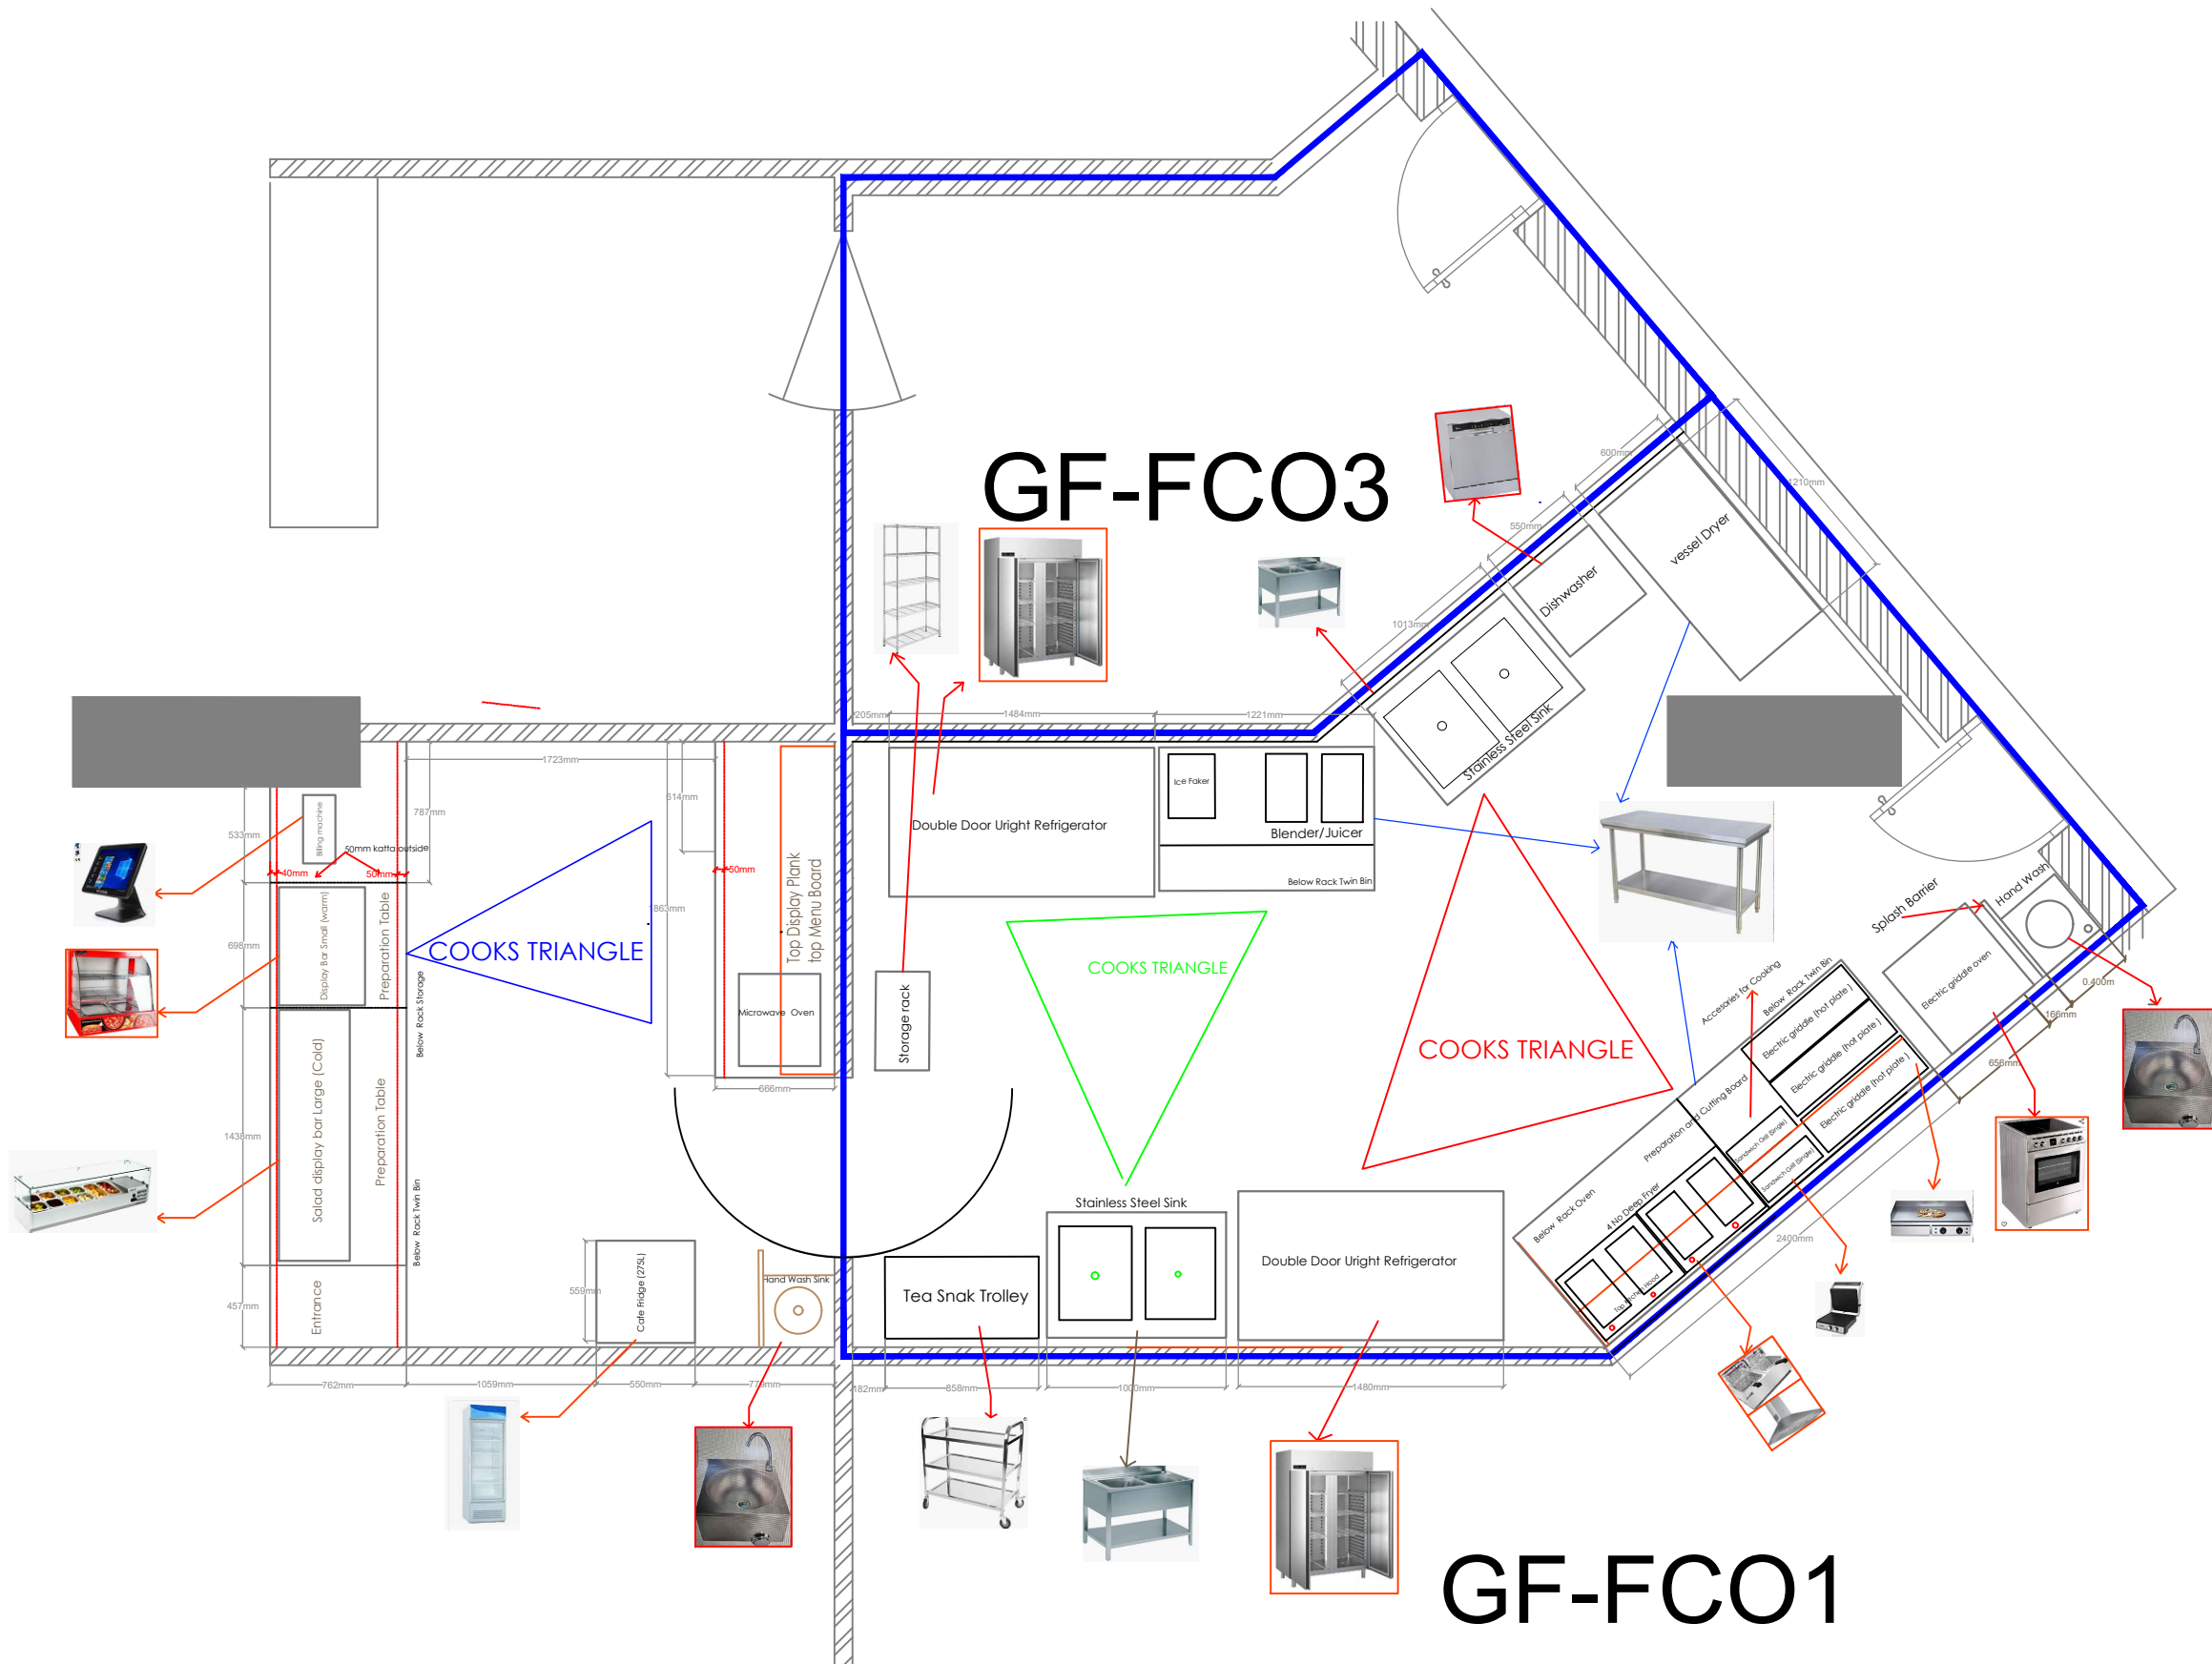

Electrical Plan

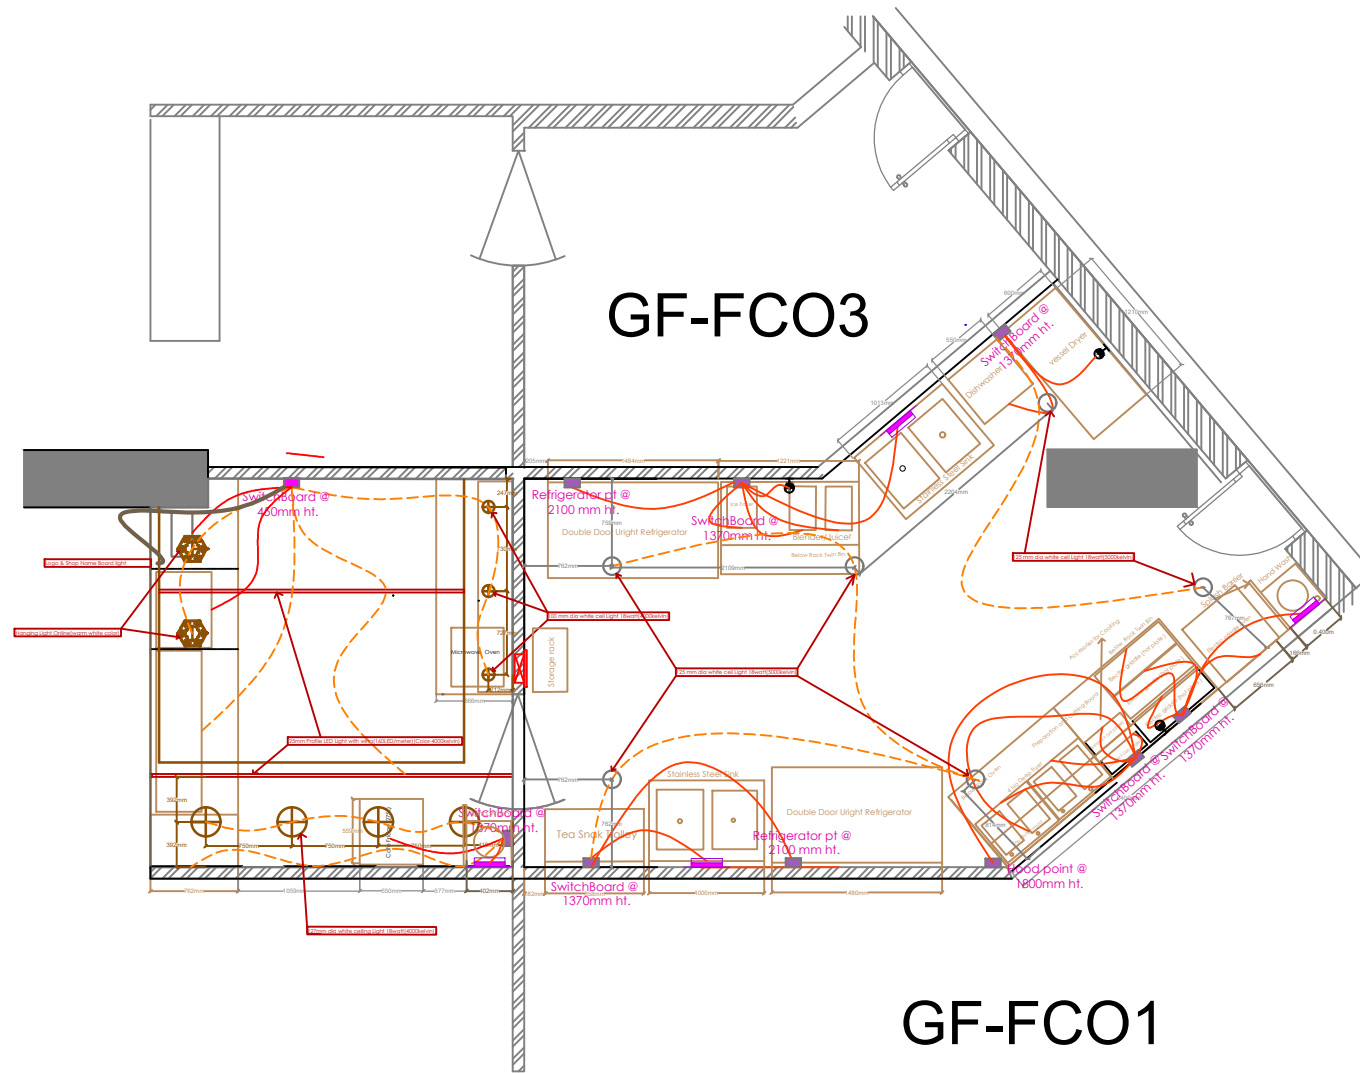

© THIS DRAWING IS THE PROPERTY OF ZA Construction (SHOP INTERIOR DESIGN) & NOT TO BE COPIED OR USED WITHOUT THEIR PERMISSION.

LEGEND	
SYMBOL	DESCRIPTION
	SWITCH BOARD
	SWITCH BOARD
	CEILING MOUNTED DOWN LIGHT
	CEILING MOUNTED ELETRIC FAN 1.2m dia
	WALL MOUNTED LIGHT PT AT 7'6"ht (2.28m)
	EXHAUST FAN
	DISTRIBUTION BOARD
	BULKHEAD FROM PLINTH
	UNDER WATER POOL LIGHT
	1 HP SUBMERSIBLE PUMP
	CALLING BELL BUZZER
	CALLING BELL POINT
	CEILING MOUNTED ELETRIC FAN 0.60M dia
	WALL MOUNTED LIGHT PT AT 6'6"ht (1.98m)
	EARTHING POINT
	POOL PUMP
	METER BOX
	TELEPHONE POINT AT 2'6"(0.76m)ht
	STARTER AT 4'6"(1.37m)ht

PROJECT
SustainAbite Cafe
at Dubai Production City

OWNER'S NAME & SIGN.
Mr.Ammar

DRAWING TITLE
 Electrical Plan


DWG. NO.	SCALE NTS	DATE 03.04.2024
	DEALT BY ABDUSSAMI	CHKD. BY SYB

SHOP INTERIOR DESIGN.

Architecture	Interiors	Construction
--------------	-----------	--------------

Gandhi nagar, 1st main opp 4th cross,
 Dharwad -580004.
 cell: 9611993020.
 zashopinteriordesign@gmail.com

Plumbing Plan

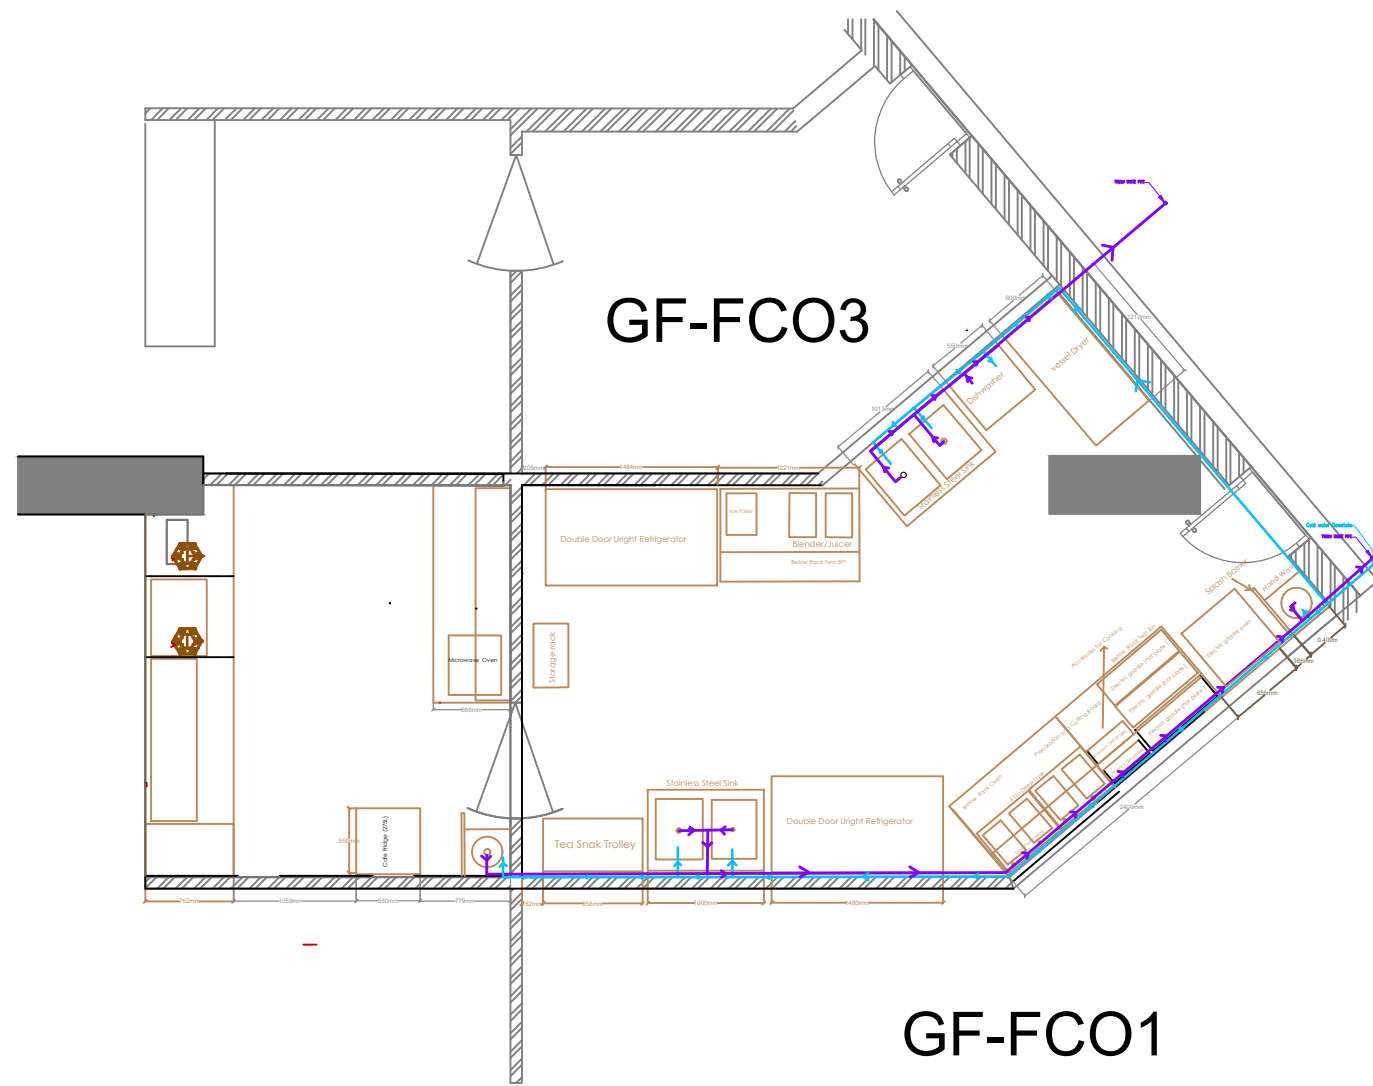

© THIS DRAWING IS THE PROPERTY OF ZA Construction (SHOP INTERIOR DESIGN) & NOT TO BE COPIED OR USED WITHOUT THEIR PERMISSION.

LEGEND	
PLUMBING LEGEND	
	PUMP LINE
	DS-DOMESTIC PIPE
	HS-HOT WATER SUPPLY
	WASTE PIPE
	SOIL PIPE
	VENT / ANTI PIPE
	40MM DRAIN PIPE
	SOIL WILEY PIPE TO POOL
	BRACKETS
	FLOOR TRAP
	GEYSER
	FLUSH TANK WITH ANGLE COCK
	SEWER RECTANGULAR MANHOLE 0.45x0.45m x 0.45m
	WATER METER
	1 HP SUBMERSIBLE PUMP
	TILE DROP 1 TILE TH
	GATE VALVE

PROJECT
SustainAbite Cafe
at Dubai Production City

OWNER'S NAME & SIGN.
Mr.Ammar

DRAWING TITLE
 Plumbing Plan


DWG. NO.	SCALE NTS	DATE 03.04.2024
	DEALT BY ABDUSSAMI	CHKD. BY SYB

SHOP INTERIOR DESIGN.

Architecture | Interiors | Construction

Gandhi nagar, 1st main opp 4th cross,
 Dharwad -580004.
 cell: 9611993020.
 zashopinteriordesign@gmail.com

Tiles Plan and Details

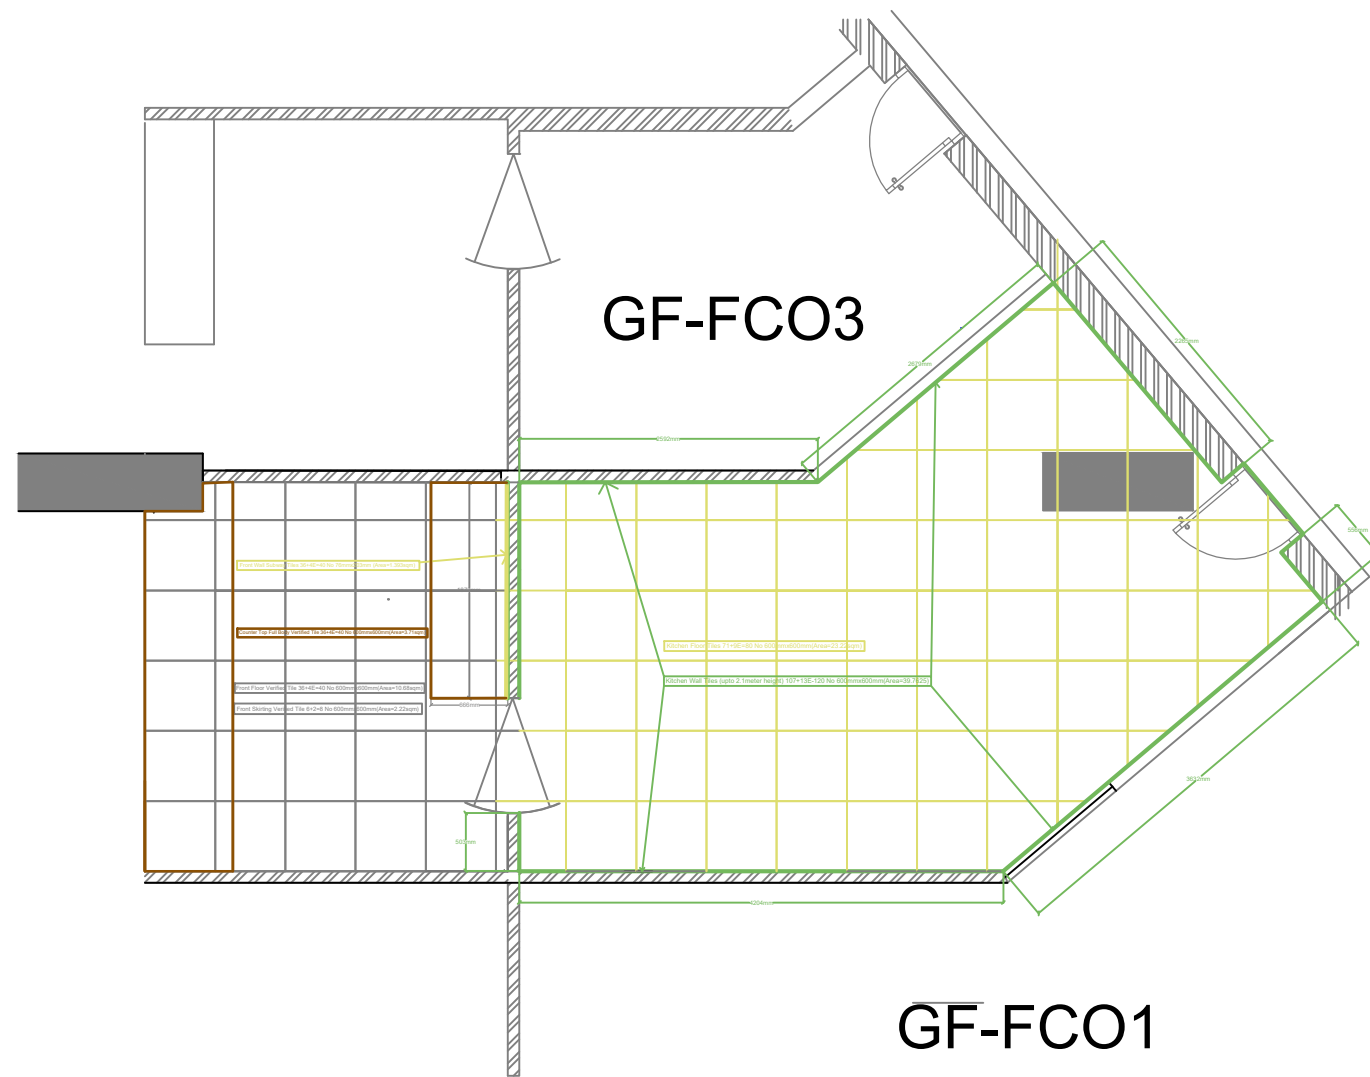

© THIS DRAWING IS THE PROPERTY OF ZA Construction (SHOP INTERIOR DESIGN) & NOT TO BE COPIED OR USED WITHOUT THEIR PERMISSION.

LEGEND	
PLUMBING LEGEND	
	PUMP LINE
	DS-DOMESTIC PIPE
	HS-HOT WATER SUPPLY
	WASTE PIPE
	SOIL PIPE
	VENT / ANTI PIPE
	40MM DRAIN PIPE
	SCUM INLET PIPE TO POOL
	BRACKETS
	FLOOR TRAP
	GEYSER
	FLUSH TANK WITH ANGLE COCK
	SEWER RECTANGULAR MANHOLE 0.45x0.45m x 0.45m
	WATER METER
	1 HP SUBMERSIBLE PUMP
	TILE DROP 1 TILE TH
	GATE VALVE

PROJECT
SustainAbite Cafe
at Dubai Production City

OWNER'S NAME & SIGN.
Mr.Ammar

DRAWING TITLE
 Plumbing Plan

DWG. NO.	SCALE NTS	DATE 03.04.2024
	DEALT BY ABDUSSAMI	CHKD. BY SYB

SHOP INTERIOR DESIGN.

Architecture | Interiors | Construction

Gandhi nagar, 1st main opp 4th cross,
 Dharwad -580004.
 cell: 9611993020.
 zashopinteriordesign@gmail.com